



LEGEND	
①+	13 AMP SINGLE GANG POWER OUTLET
②+	13 AMP DOUBLE GANG POWER OUTLET
①	FLOOR MOUNTED 13 AMP SINGLE GANG POWER OUTLET
②	FLOOR MOUNTED 13 AMP DOUBLE GANG POWER OUTLET
WP	WATERPROOF SINGLE GANG POWER OUTLET
△	TELEPHONE POINT
△	FLOOR MOUNTED TELEPHONE POINT
SCV	TV ANTENNA POINT
SCV	FLOOR MOUNTED TV ANTENNA POINT
DA	DATA POINT
DA	FLOOR MOUNTED DATA POINT
HR	HUMIDIFIER
IT	VISUAL INTERCOM
CC	CCTV
CC	DOME CAMERA COLOUR PANTILD
E	ELECTRICAL APPLIANCES

NOTE : ALL POWERPOINT TO BE 300MM ABOVE FFL UNLESS OTHERWISE STATED

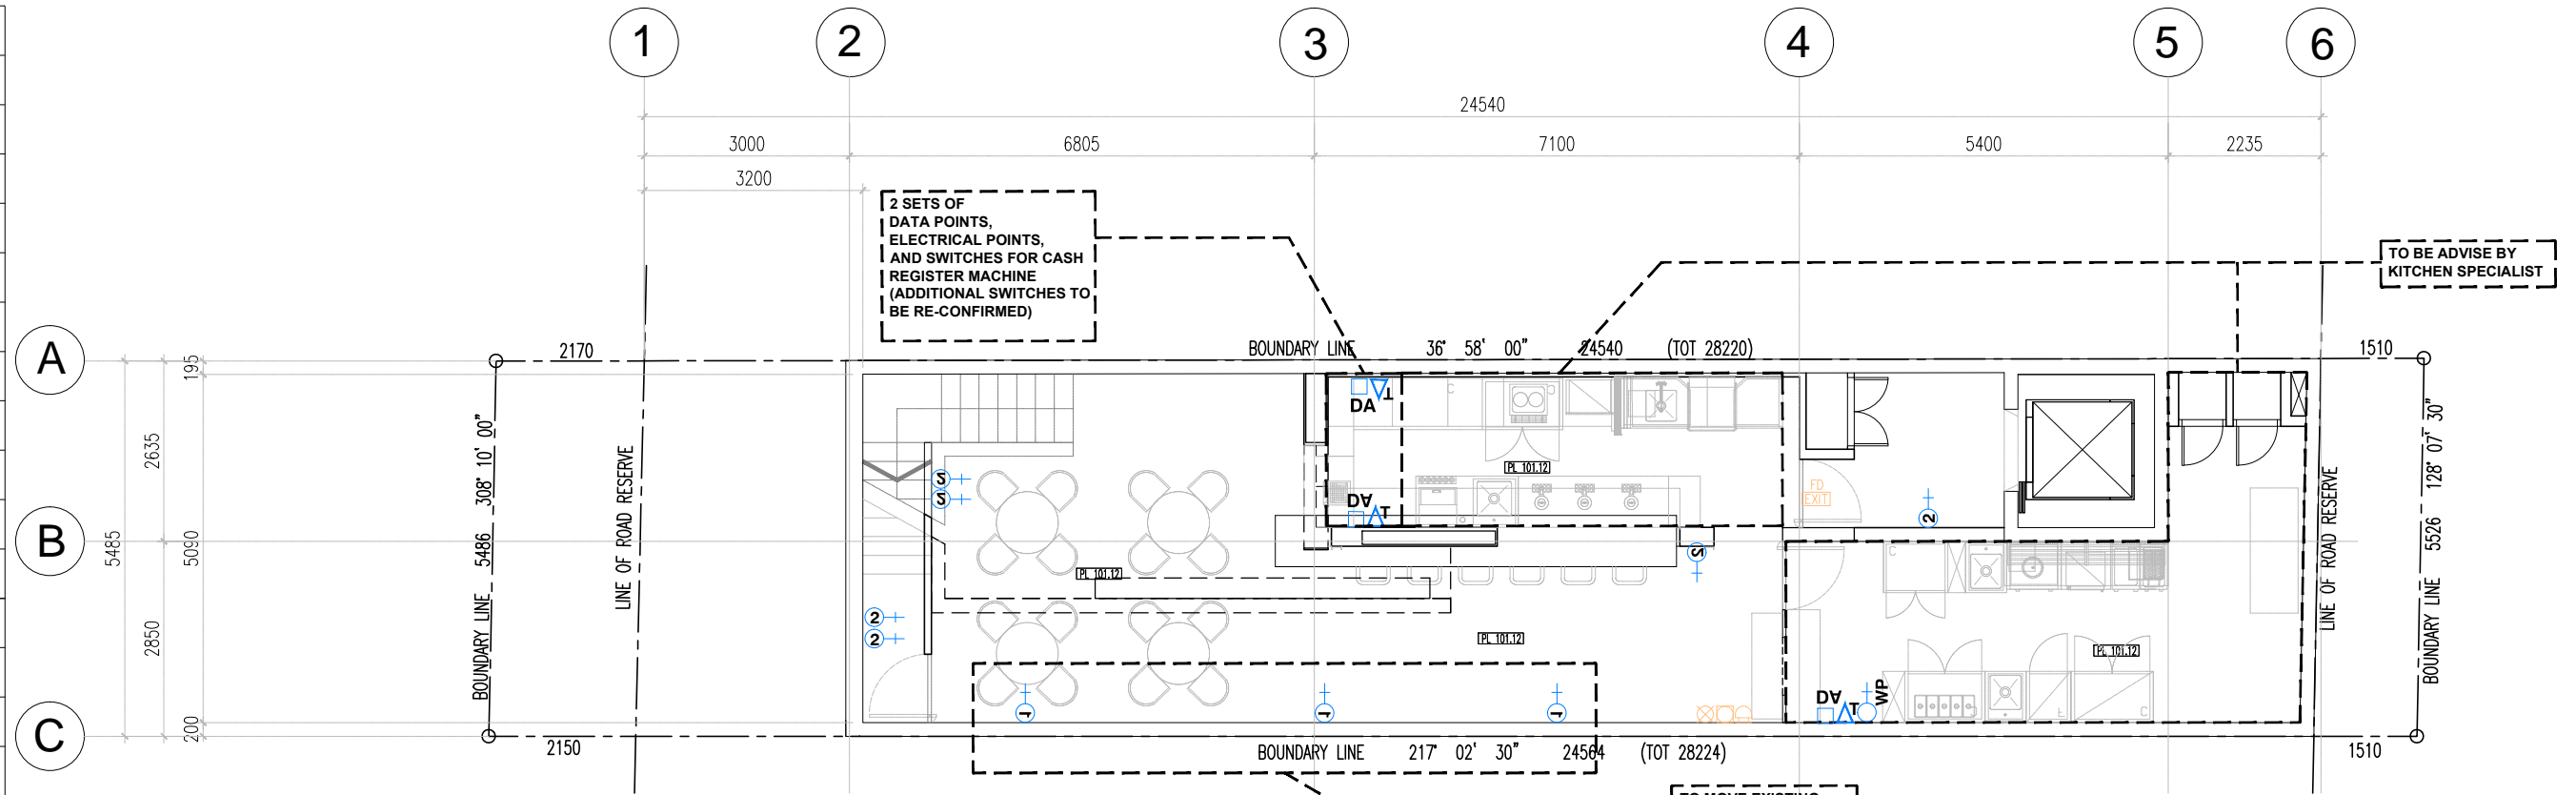

F500 ELECTRICAL PLAN - BASEMENT
F500.01 SCALE 1:100

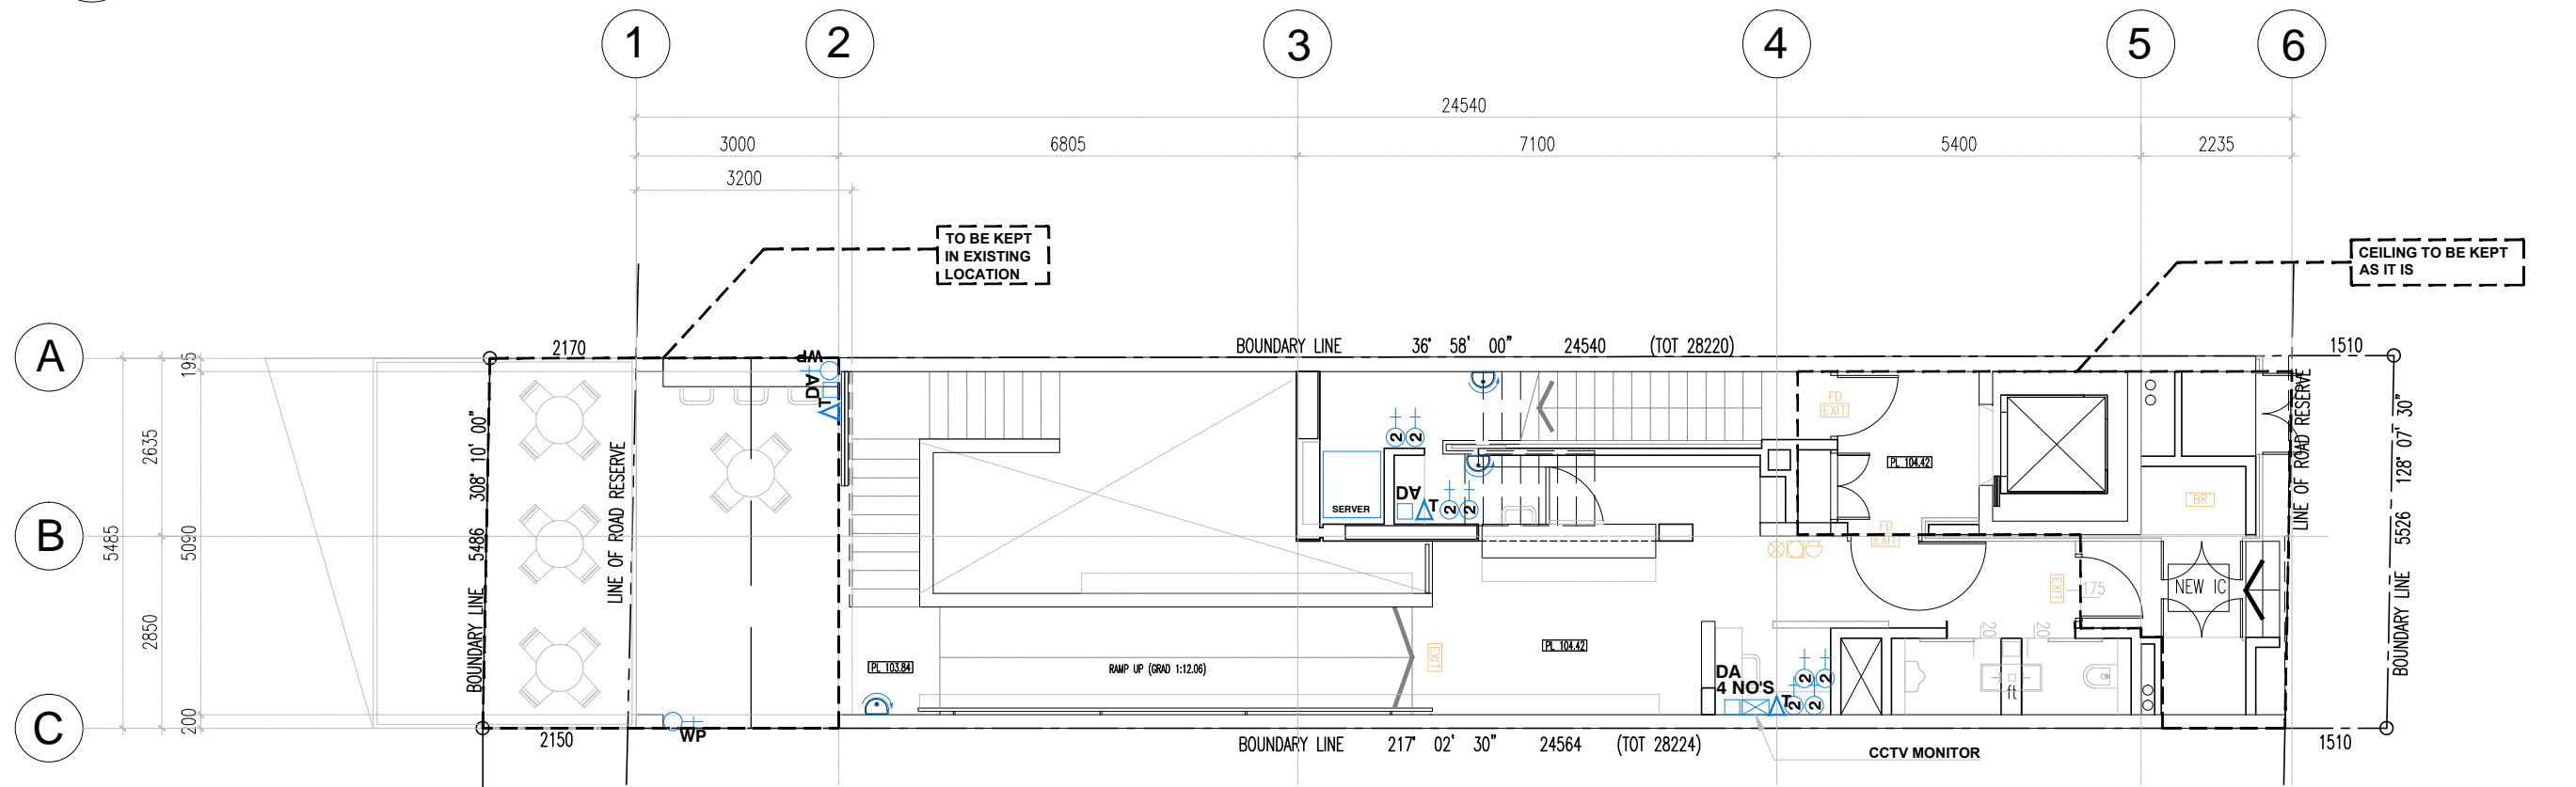

F500 ELECTRICAL PLAN - FIRST STOREY
F500.02 SCALE 1:100

THE PLANS + INFORMATION SHOWN ARE SUBJECT TO CHANGES + DEVIATIONS REQUIRED BY OR APPROVED BY THE VARIOUS RELEVANT AUTHORITIES.

ALL STRUCTURAL MEMBERS SIZES TO BE VERIFIED BY PE
 CONTRACTORS SHALL WORK FROM FIGURED DIMENSIONS ONLY. CONTRACTORS MUST CHECK ALL DIMENSIONS ON SITE. DISCREPANCIES MUST BE REPORTED IMMEDIATELY TO THE ARCHITECT.

DATE	DESCRIPTION	REV. NO.	DESCRIPTION	REV. NO.

MR. PUNCH REST - MINT TOY MUSEUM
ELECTRICAL PLAN
BASEMENT AND 1ST STOREY PLAN

RT + Q
 ARCHITECTS

32A Mosque Street
 Singapore 059510
 Tel: 6221 1366 Fax: 6222 2080

SCALE :	
DATE :	
DRAWN :	
ARCHITECT :	RENE TAN
PROJECT NO :	13279
DRAWING NO :	G500/02A

FILE : © COPYRIGHT